

**Carmina
Wood
Morris^{PC}**

487 Main Street Suite 600
Buffalo, New York 14203
P 716.842.3165
F 716.842.0283

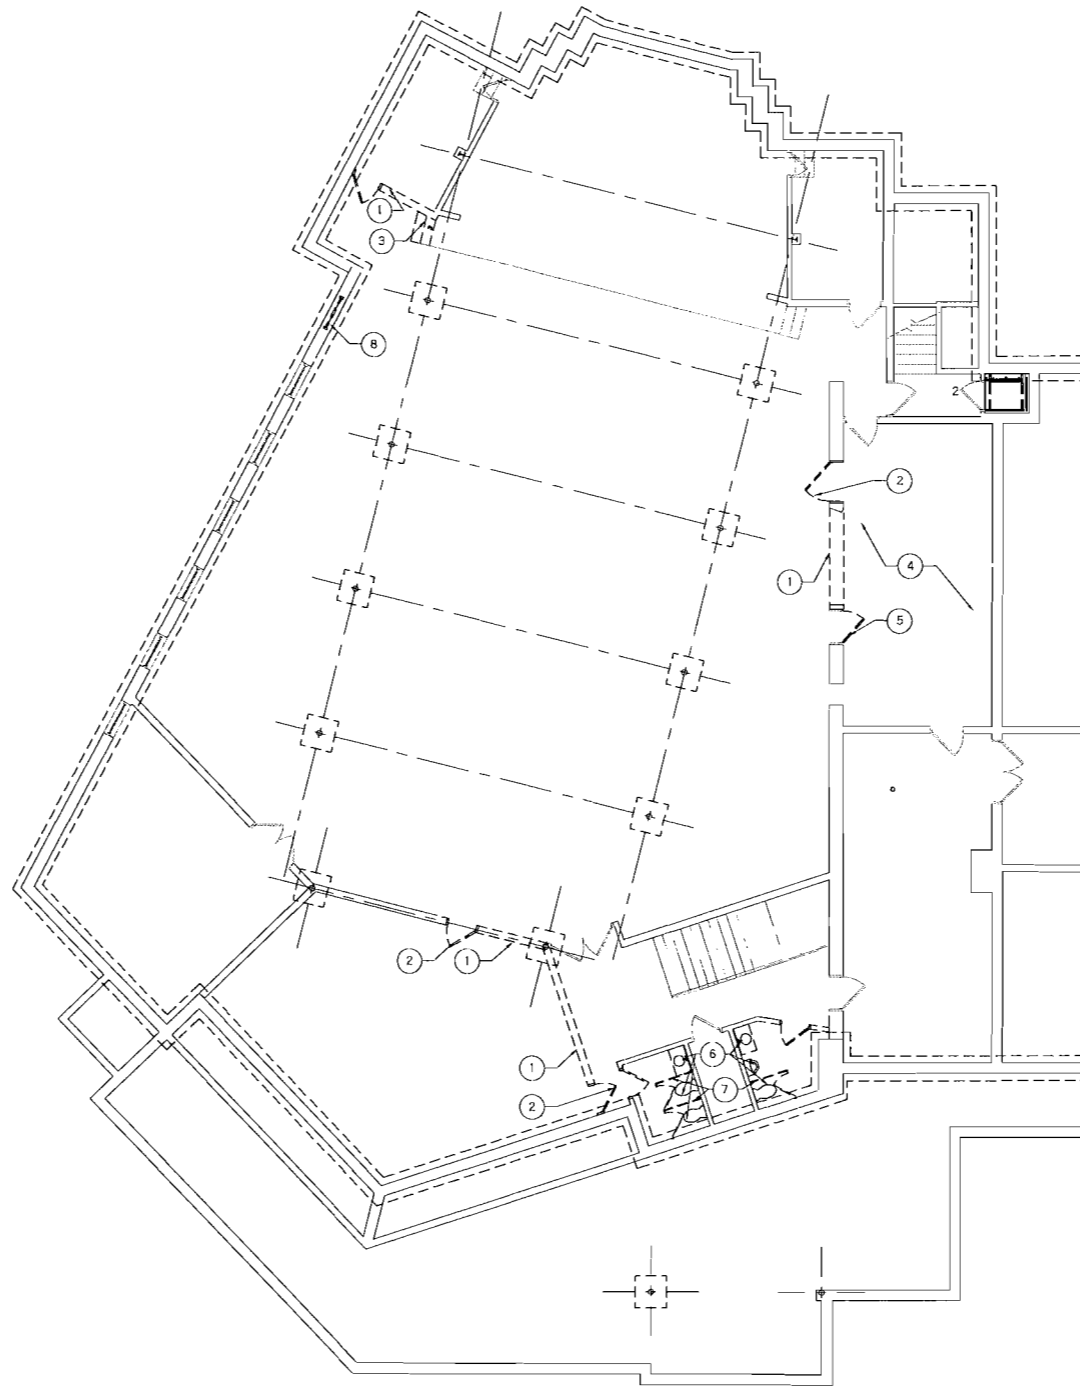
REVISIONS: No.	Description	Date

PROJECT NAME:
Renovations and Alterations for:
First Trinity Lutheran Church
Youth Ministry Center
1570 Niagara Falls Blvd.
Tonawanda, New York 14150

Date: _____ Date
Drawn by: M. Fischer
Scale: As Noted

DRAWING NAME:
Reflected
Ceiling Plan

DRAWING NO.
A-300
Project no.: 08.026



 
 


DEMOLITION FLOOR PLAN

1/8"=1'-0"

DEMOLITION NOTES:

- ① EXISTING PARTITION WALLS TO BE REMOVED AND DISCARDED IN A PROPER MANNER. PATCH AREAS WHERE INTERSECTING WALLS WERE REMOVED FROM REMAINING WALLS AS NECESSARY IN PREPARATION FOR NEW FINISHES.
- ② EXISTING DOOR & FRAME TO BE REMOVED AND DISCARDED IN A PROPER MANNER.
- ③ REMOVE EXISTING STAIR AND HANDRAIL CONSTRUCTION AND DISCARD IN A PROPER MANNER.
- ④ REMOVE EXISTING MILLWORK FROM AFFECTED AREA OF NEW CONSTRUCTION AND DISCARD IN A PROPER MANNER.
- ⑤ EXISTING DOOR TO BE REMOVED. EXISTING FRAME TO REMAIN. REPAIR AS REQUIRED.
- ⑥ COORDINATE WITH OWNER AS TO THE REMOVAL AND DISPOSAL OF EXISTING PLUMBING FIXTURES. IF FIXTURES ARE TO BE PRESERVED, REMOVE CAREFULLY AND STORE IN A SAFE LOCATION DESIGNATED BY OWNER. IF FIXTURE IS TO BE COMPLETELY DEMOLISHED, DISPOSE OF THEM IN A PROPER MANNER. PREPARE REMAINING UTILITIES FOR NEW CONSTRUCTION.
- ⑦ REMOVE EXISTING TOILET PARTITIONS AND DISPOSE OF IN A PROPER MANNER. PREPARE REMAINING SURFACES FOR NEW CONST.

DEMOLITION LEGEND:

-  EXISTING WALL TO REMAIN
-  EXISTING WALL TO BE REMOVED FOLLOW INSTRUCTION FOR REMOVAL AS OUTLINED IN THE DEMOLITION NOTES.
-  EXISTING DOOR TO BE REMOVED FOLLOW INSTRUCTIONS FOR REMOVAL AS OUTLINED IN THE DEMOLITION NOTES
-  EXISTING DOOR TO REMAIN



**Carmina
Wood
Morris^{PC}**
487 Main Street Suite 600
Buffalo, New York 14203
P 716.842.3165
F 716.842.0263

REVISIONS:	Date
No. Description	

PROJECT NAME:

Renovations and Alterations for:
First Trinity Lutheran Church
Youth Ministry Center
1570 Niagara Falls Blvd.
Tonawanda, New York 14150

Date:
Drawn by: M. Fischer
Scale: As Noted

DRAWING NAME:
Demolition
Floor Plan

DRAWING NO.
D-100

Project no.: 08.026